


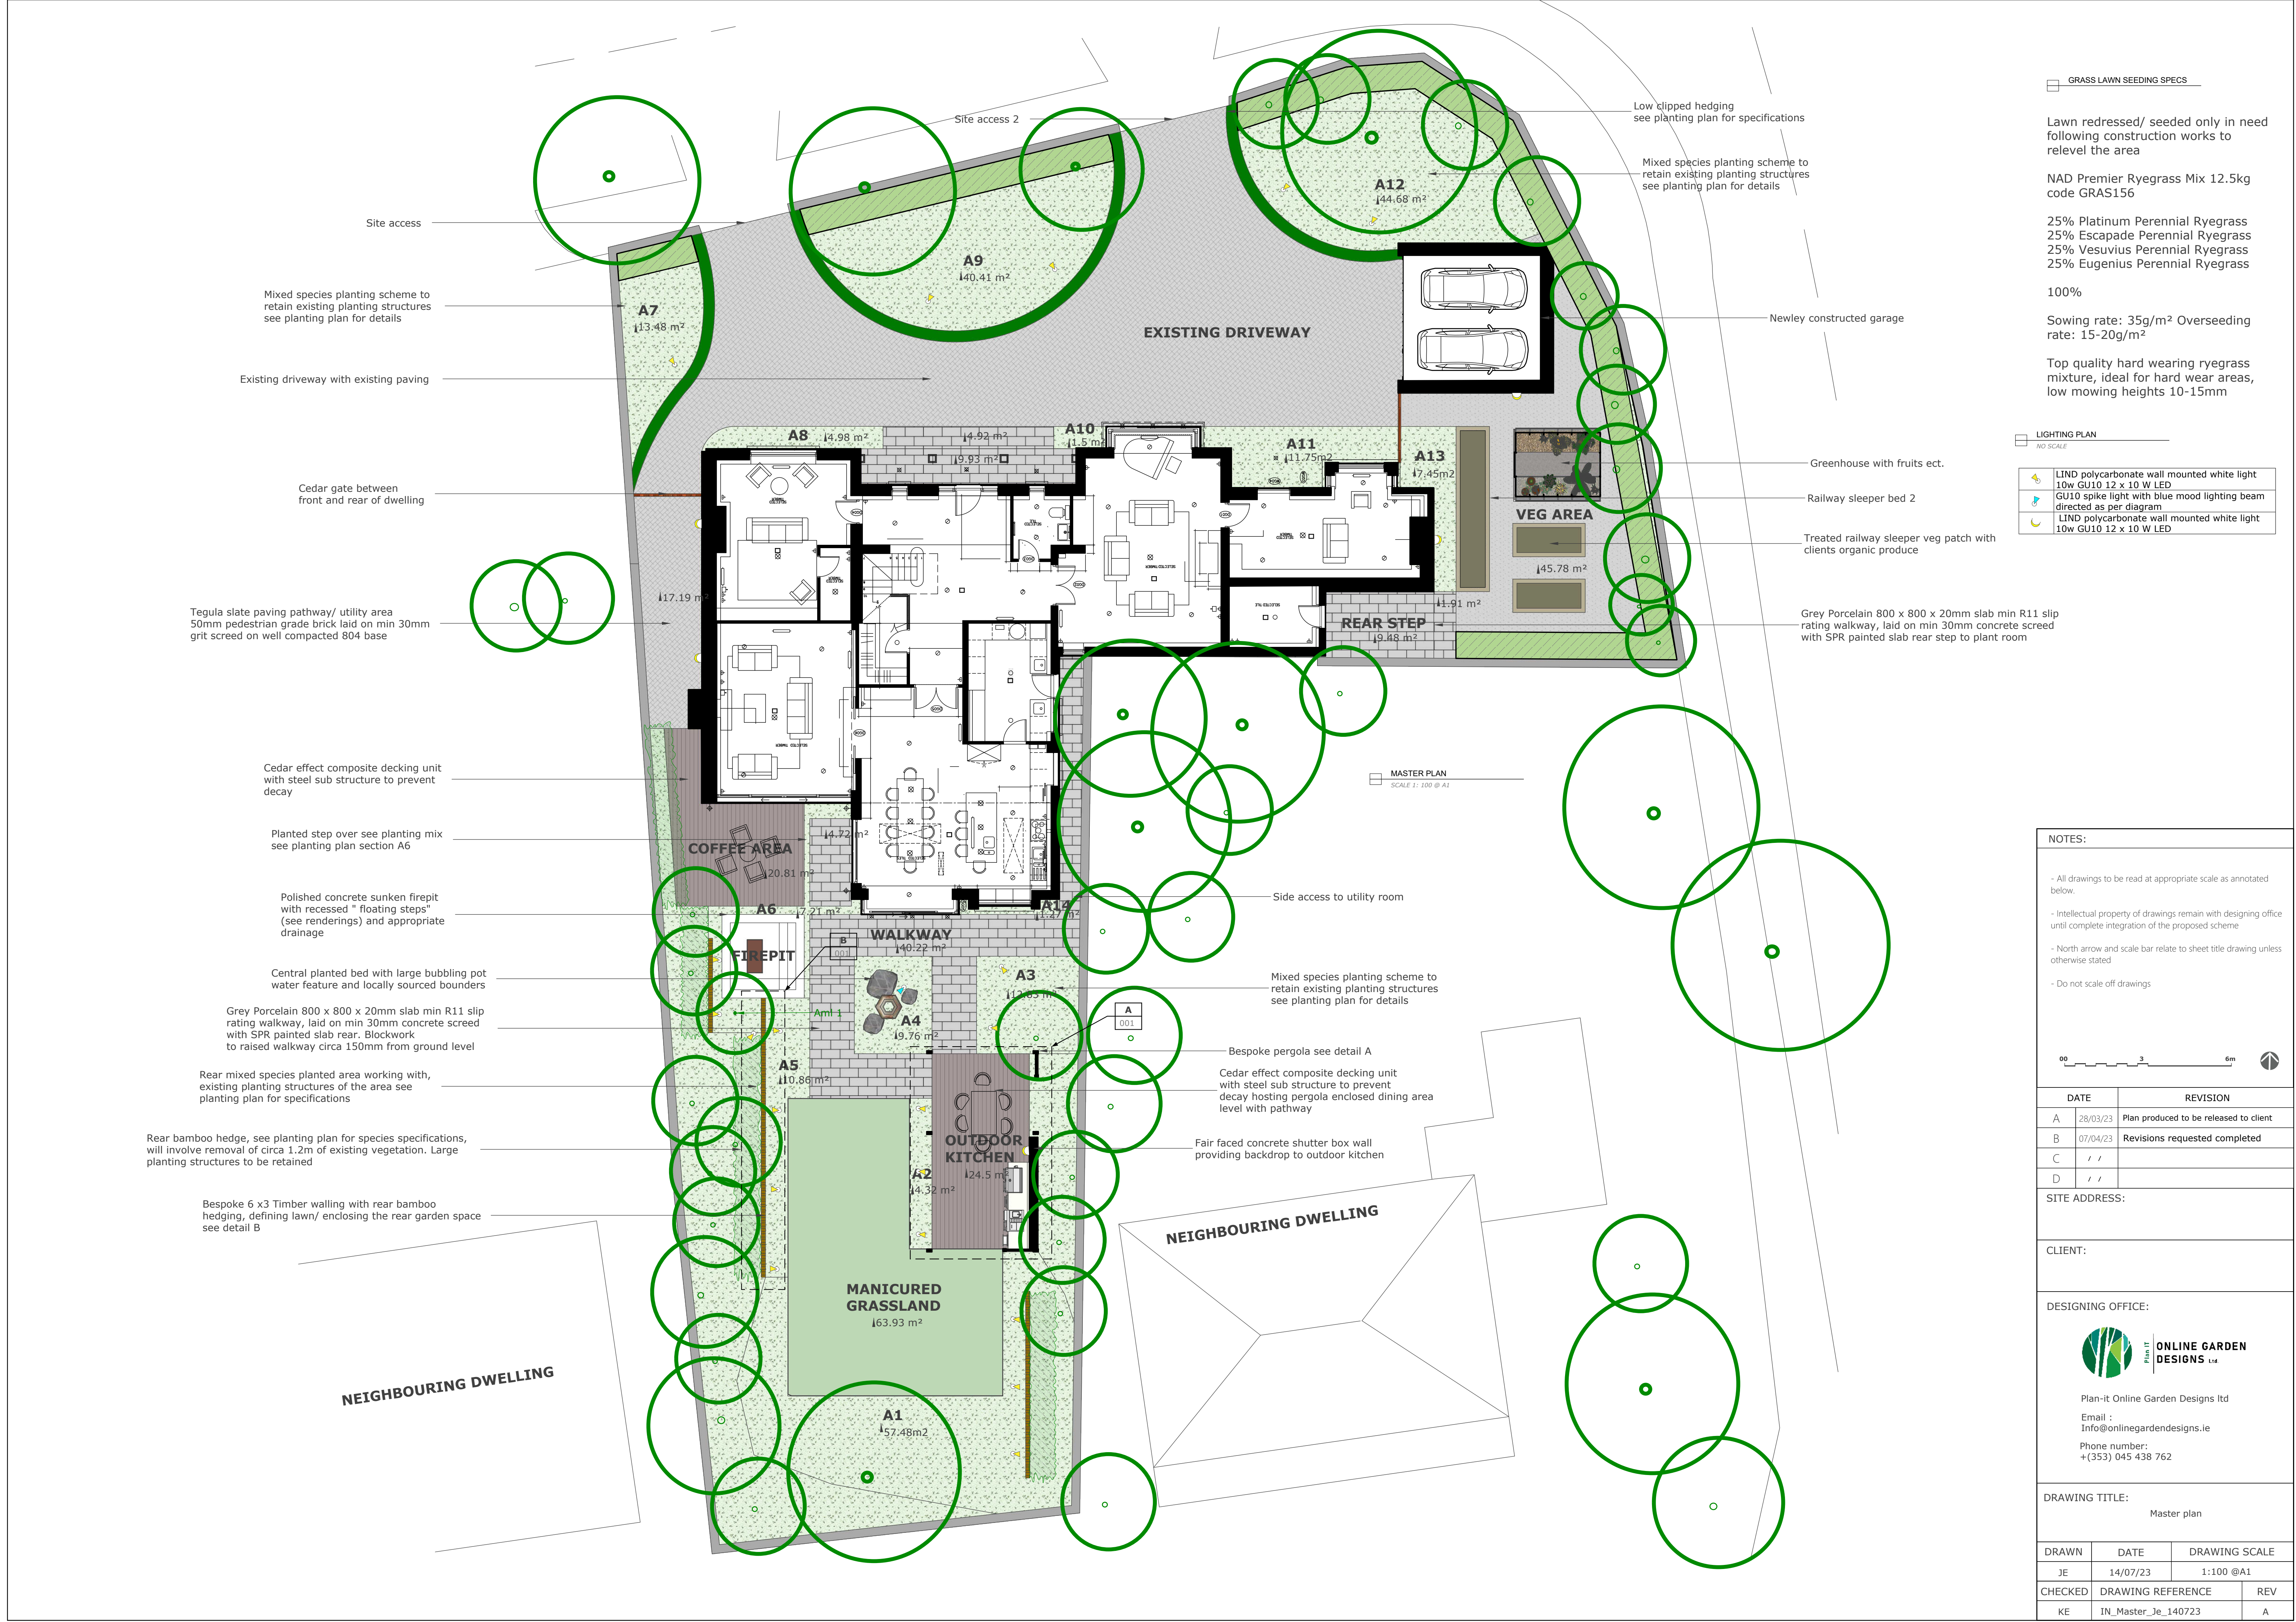

GRASS LAWN SEEDING SPECS

Lawn redressed/ seeded only in need following construction works to relevel the area

NAD Premier Ryegrass Mix 12.5kg code GRAS156

25% Platinum Perennial Ryegrass
25% Escapade Perennial Ryegrass
25% Vesuvius Perennial Ryegrass
25% Eugenius Perennial Ryegrass

100%
Sowing rate: 35g/m² Overseeding rate: 15-20g/m²


Top quality hard wearing ryegrass mixture, ideal for hard wear areas, low mowing heights 10-15mm

LIGHTING PLAN

NO SCALE	
	LIND polycarbonate wall mounted white light 10w GU10 12 x 10 W LED
	GU10 spike light with blue mood lighting beam directed as per diagram
	LIND polycarbonate wall mounted white light 10w GU10 12 x 10 W LED

NOTES:

 - All drawings to be read at appropriate scale as annotated below.
- Intellectual property of drawings remain with designing office until complete integration of the proposed scheme
- North arrow and scale bar relate to sheet title drawing unless otherwise stated
- Do not scale off drawings



DATE	REVISION
A 28/03/23	Plan produced to be released to client
B 07/04/23	Revisions requested completed
C / /	
D / /	

SITE ADDRESS:

CLIENT:

DESIGNING OFFICE:



ONLINE GARDEN
DESIGNS LTD

Plan-it Online Garden Designs Ltd
Email :
Info@onlinegardendesigns.ie
Phone number:
+(353) 045 438 762

DRAWING TITLE:

Master plan

DRAWN	DATE	DRAWING SCALE
JE	14/07/23	1:100 @A1
CHECKED	DRAWING REFERENCE	REV
KE	IN_Master_Je_140723	A