


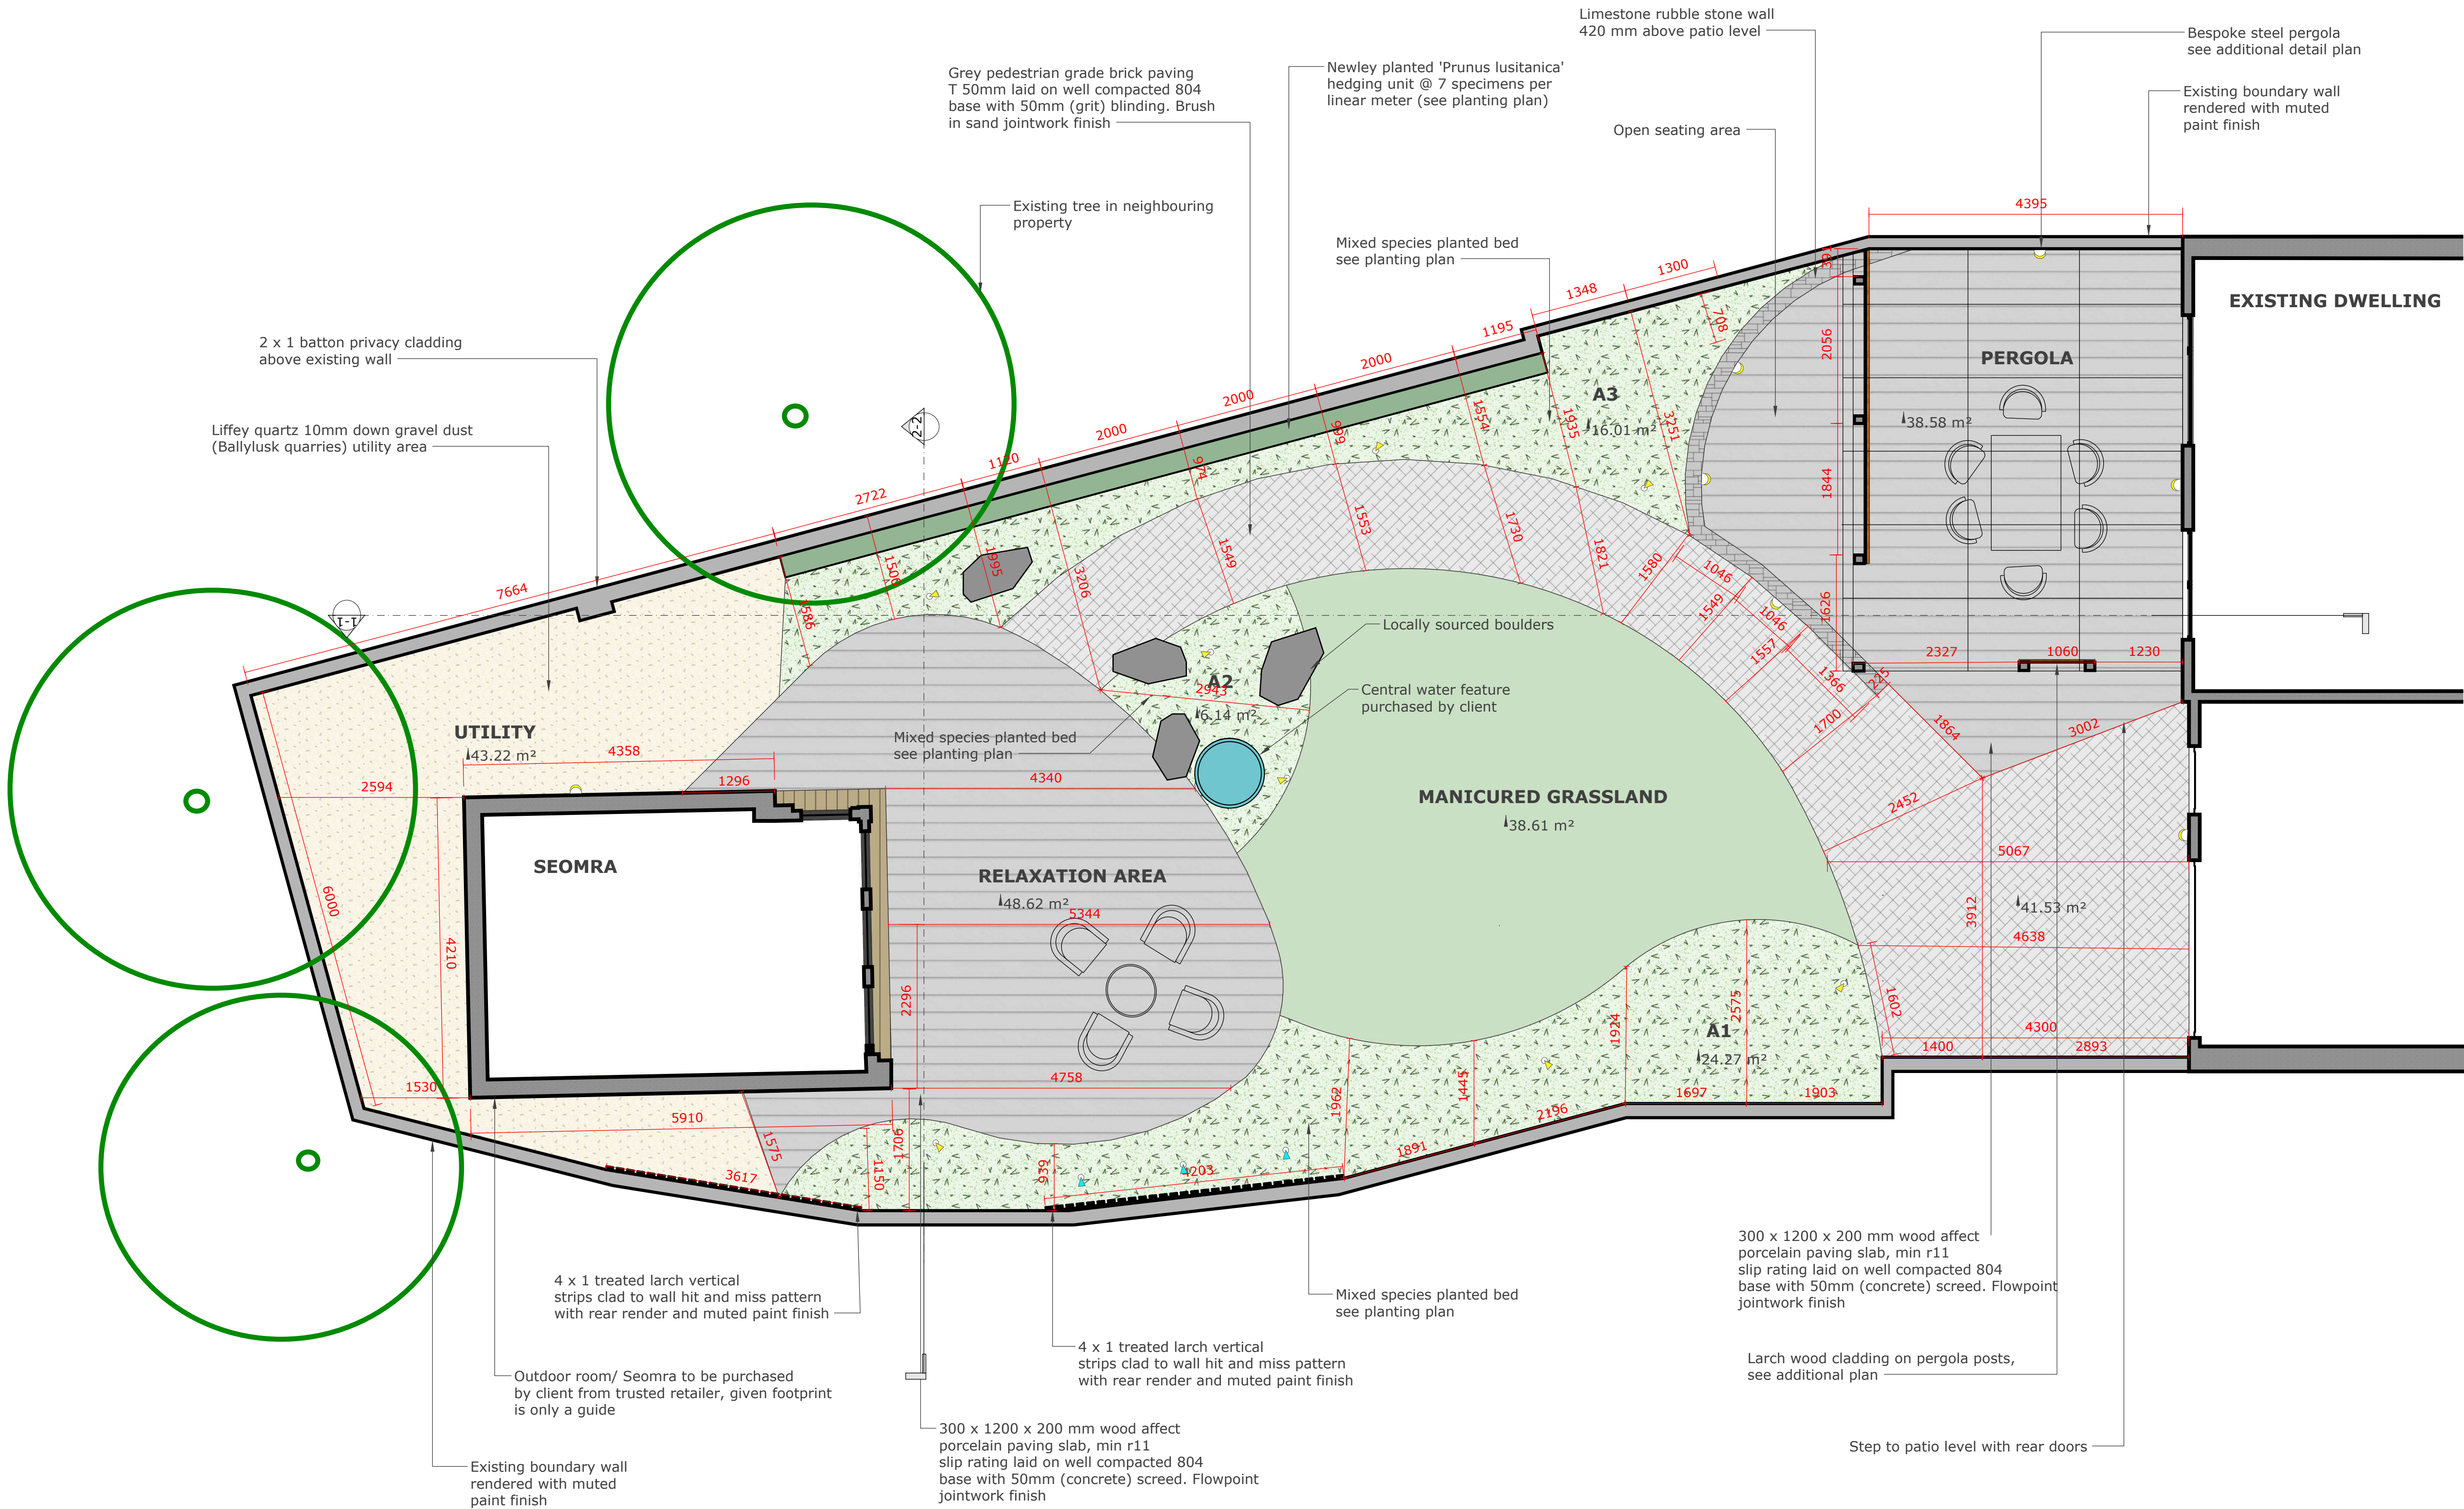

- LIND polycarbonate wall mounted white light 10w GU10 12 x 10 W LED
- GU10 spike light with blue mood lighting beam directed as per diagram
- LIND polycarbonate wall mounted white light 10w GU10 12 x 10 W LED

LIGHTING PLAN
NO SCALE

NOTES:

- All drawings to be read at appropriate scale as annotated below.
- All measurements must be checked before any construction begins on site. Any discrepancies in measurement must be reported to the designing office immediately.
- Intellectual property of drawings remain with designing office until complete integration of the proposed scheme
- North arrow and scale bar relate to sheet title drawing unless otherwise stated
- Do not scale off drawings

DATE	REVISION
A 28/03/23	Plan produced to be released to client
B 17/06/23	Revisions requested completed
C / /	
D / /	

CLIENT:

DESIGNING OFFICE:



Plan-It Online Garden Designs Ltd
Email :
Info@onlinegardendesigns.ie
Phone number:
+(353) 045 438 762

DRAWING TITLE:

Master plan

DRAWN	DATE	DRAWING SCALE
JE	17/06/23	1:50 @ a1
CHECKED	DRAWING REFERENCE	REV
KE	SC_MASTER_JE_170623	A